



© Copyright 2007

OSBORN SHARP ASSOCIATES Architecture Planning Energy Management A-F000073  
2477 Shikney Point Road - Suite 114A - Sarasota, Florida 34231 TEL 941.922.5666 FAX 941.924.9820

NEW MASJID  
SARASOTA, FL.  
4350 LOCKWOOD RIDGE ROAD  
1.S.S.B.

W.T. OSBORN  
AR-0006998

SITE  
LIGHTING  
PLAN

Job No.: 05108  
Date: 17 APRIL 08  
Sheet No.:


SL.1



SITE LIGHTING PLAN  
1/16"=1'-0"

**POLE DESCRIPTION**

POLE WITH SINGLE W4PL50  
POLE HEIGHT: 30 FEET  
AIMING ANGLE: 30 DEGREES

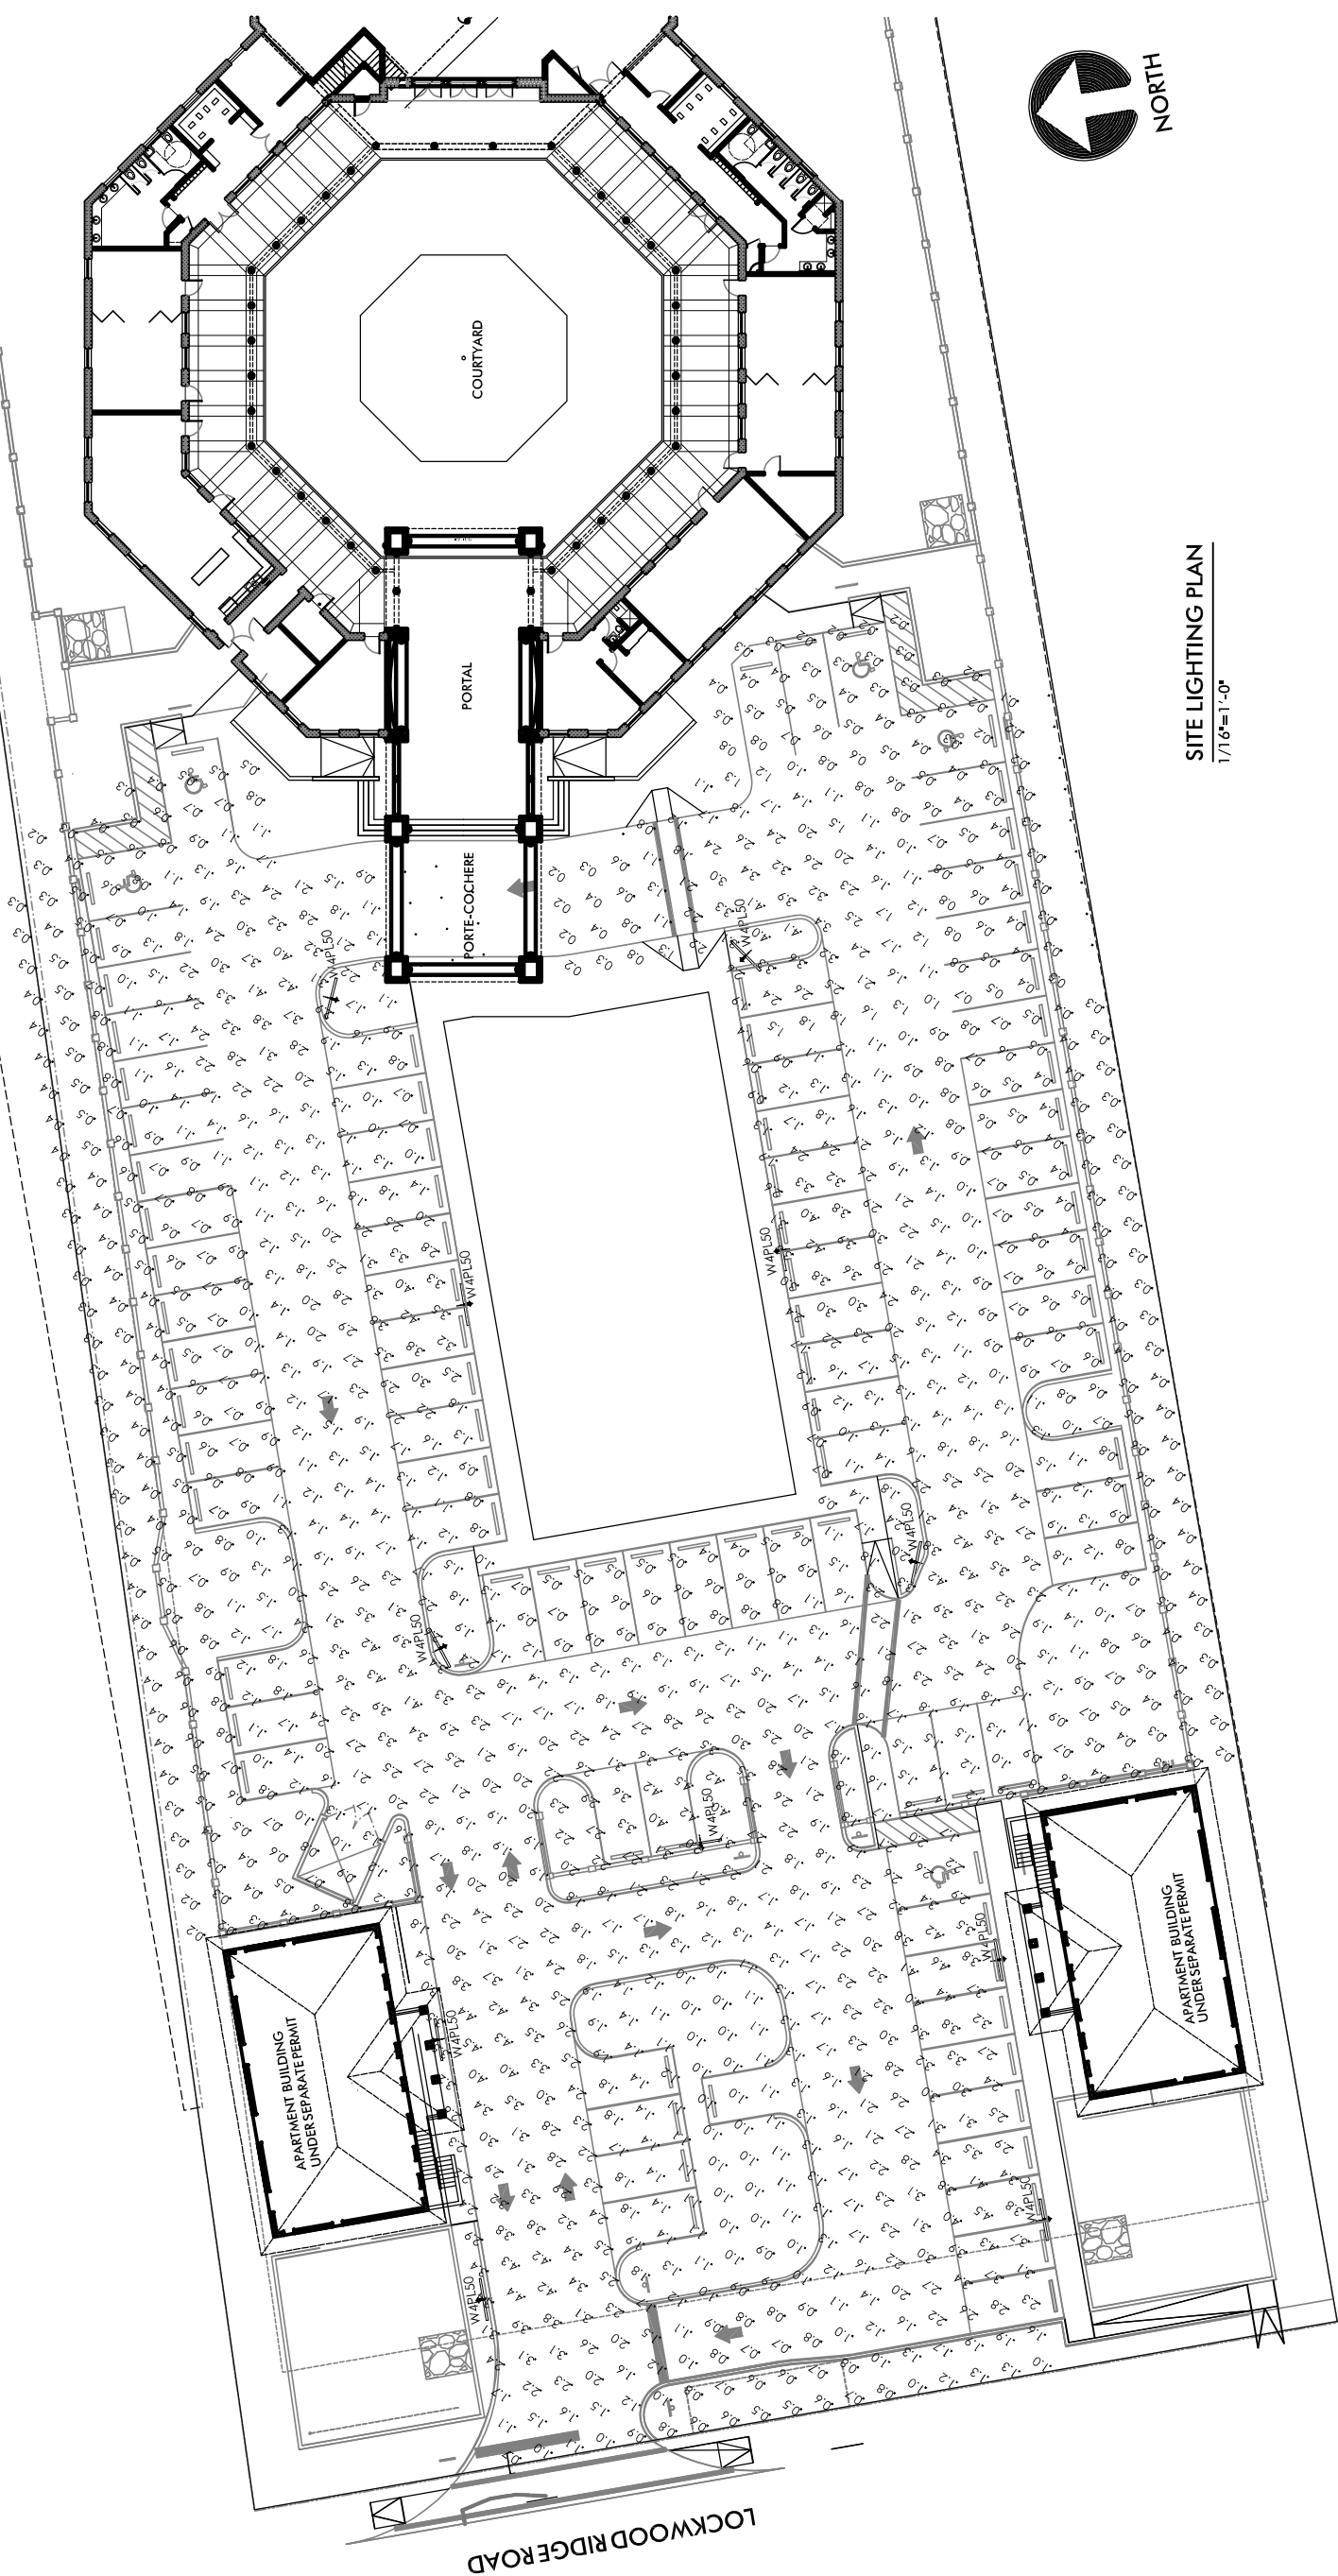

LOCKWOOD RIDGE ROAD

APARTMENT BUILDING  
UNDER SEPARATE PERMIT

APARTMENT BUILDING  
UNDER SEPARATE PERMIT

COURTYARD

PORTAL

PORTE-COCHERE

W4PL50

W4PL50

